


© 4TH D PLANNING & DESIGN

ANY FORM OF REPRODUCTION OF THIS DRAWING IN FULL OR IN PART WITHOUT THE WRITTEN PERMISSION OF 4TH D PLANNING & DESIGN CONSTITUTES AN INFRINGEMENT OF COPYRIGHT

Rev	Description	By	Date
A	PRE DA ISSUE	JA	25.10.12
B	DA ISSUE	JA	29.01.13

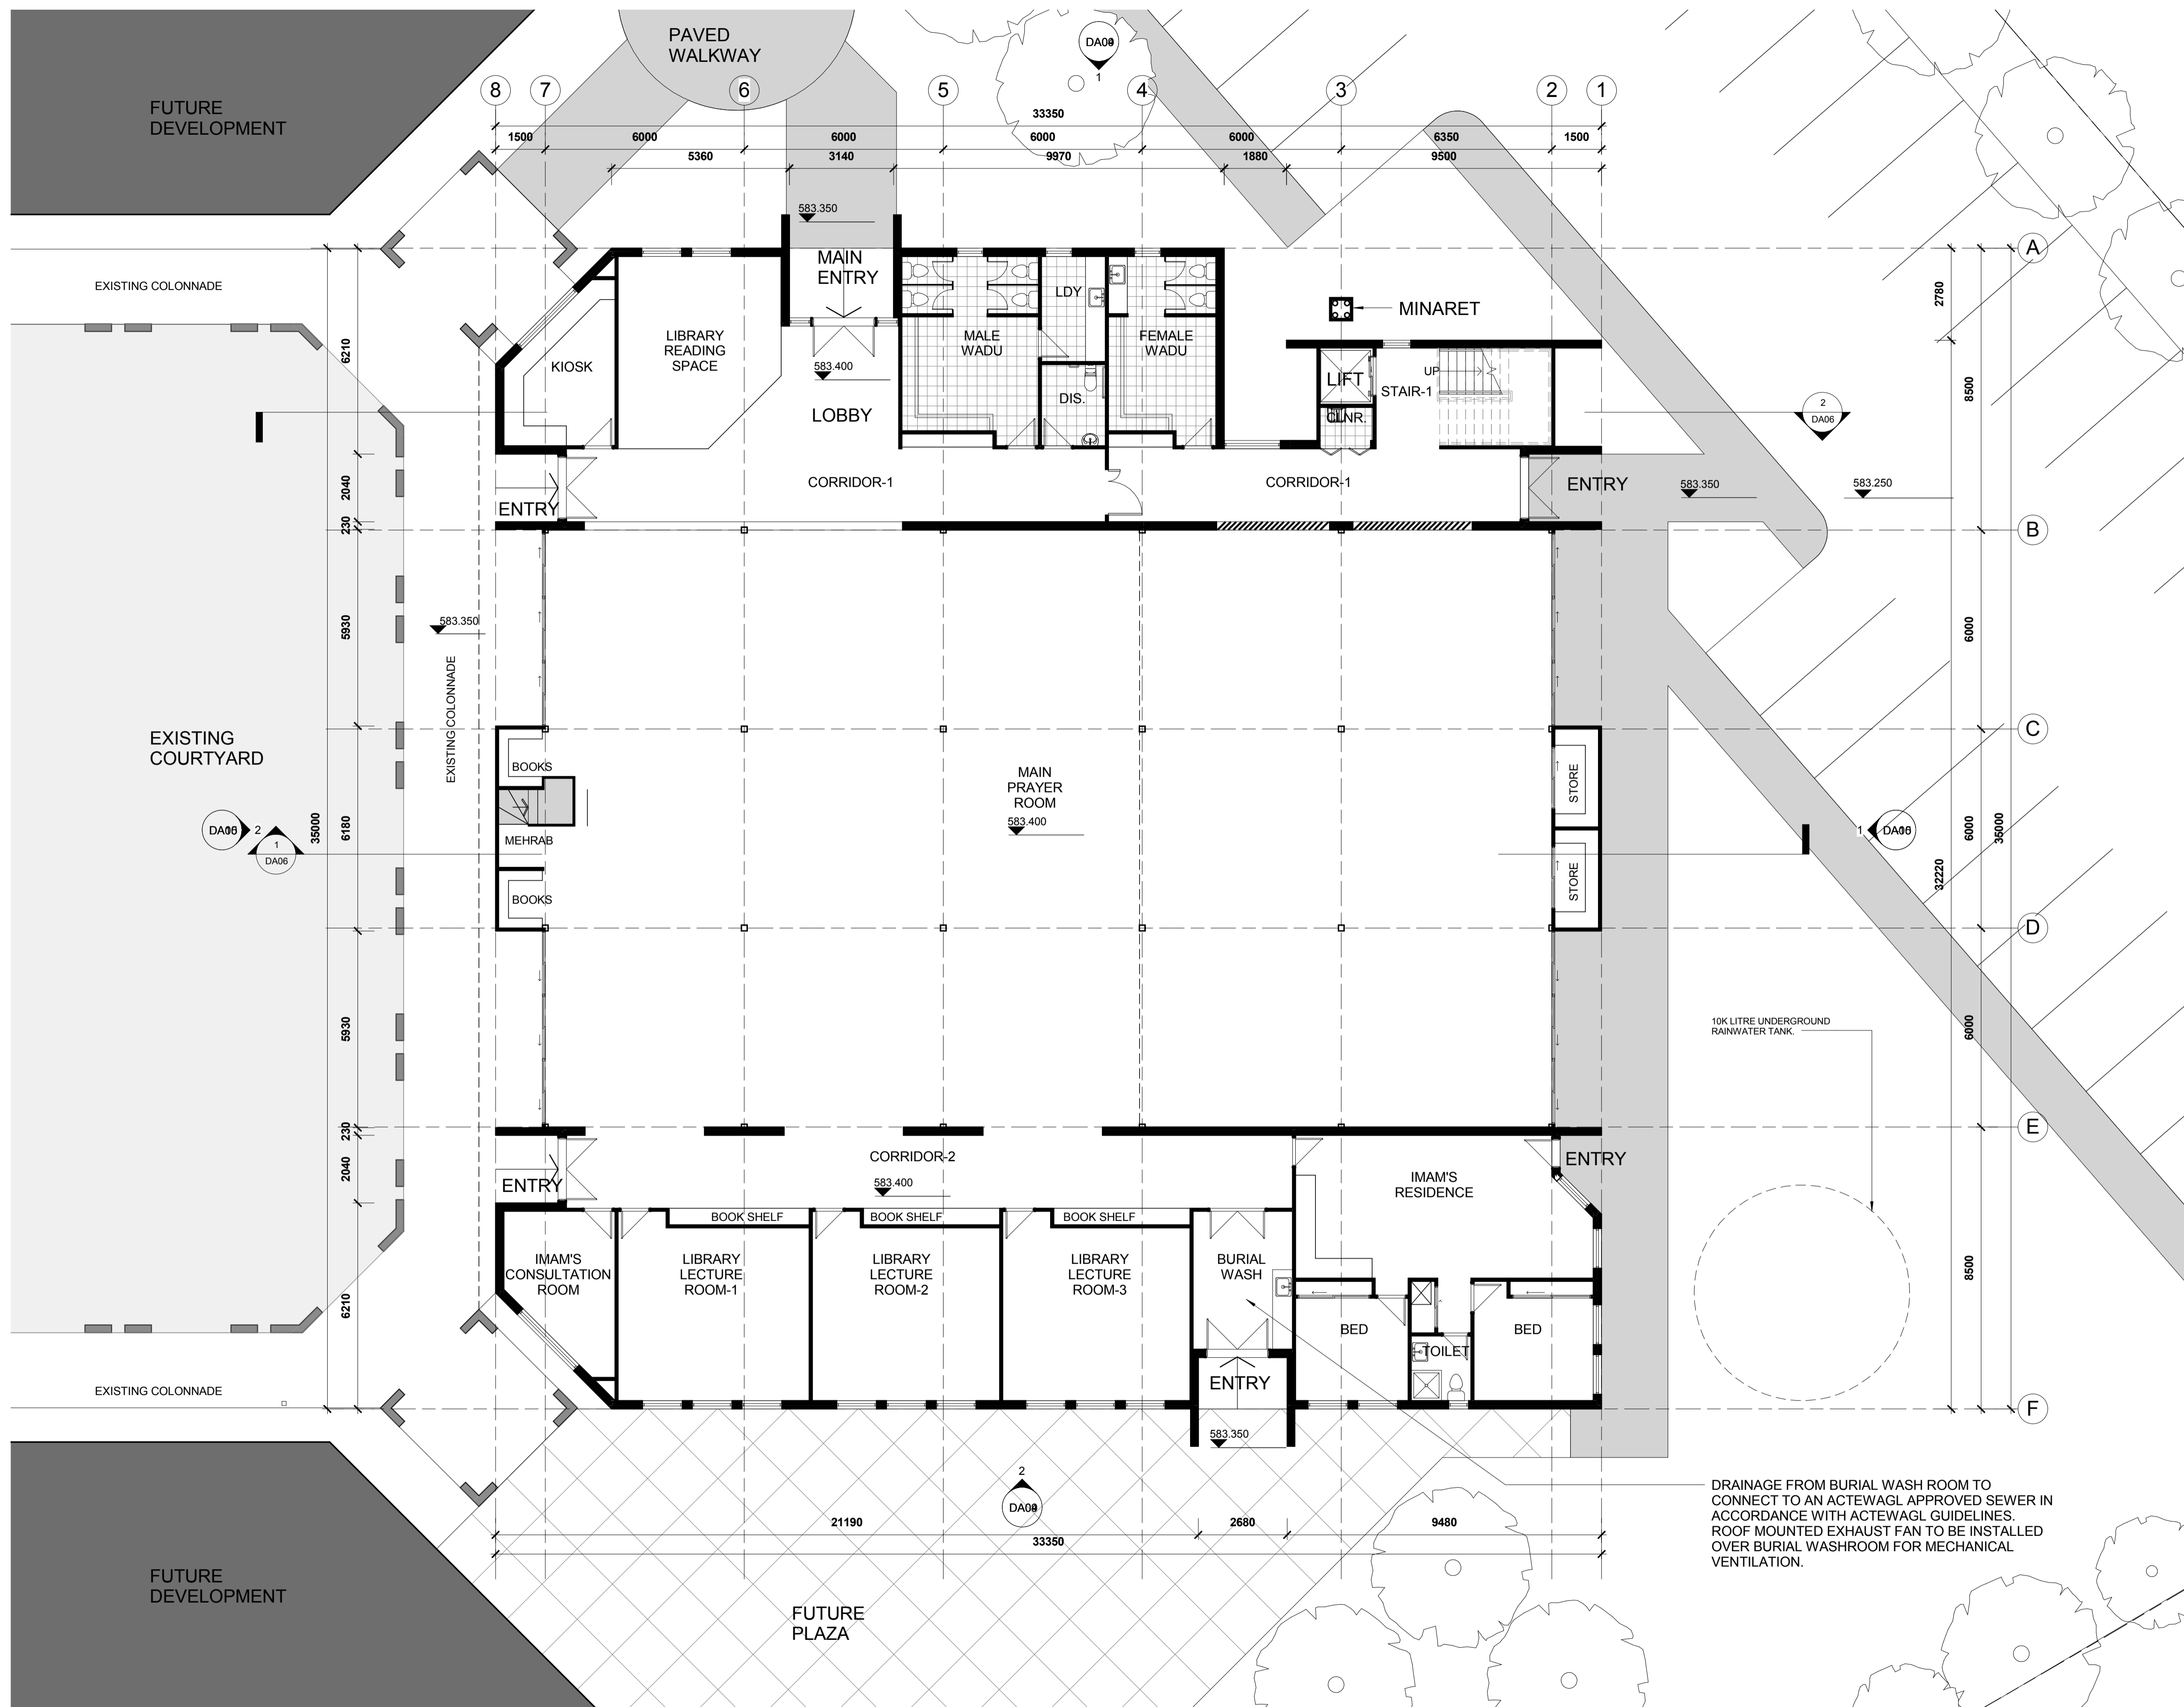

DRAINAGE FROM BURIAL WASH ROOM TO CONNECT TO AN ACTEWAGL APPROVED SEWER IN ACCORDANCE WITH ACTEWAGL GUIDELINES. ROOF MOUNTED EXHAUST FAN TO BE INSTALLED OVER BURIAL WASHROOM FOR MECHANICAL VENTILATION.

4thD PLANNING & DESIGN
 35 Clem Hill Street, Gordon ACT 2906
 Tel: (02) 6294 8059 Mob: 0434674176
 Email: info@4thd.com.au Web: www.4thd.com.au
 ACN: 154 870 078

Consultants

QUANTITY SURVEYOR
-

STRUCTURAL ENGINEER
-

CIVIL & HYDRAULIC ENGINEER
-

BCA CONSULTANT
-

CONSTRUCTION MANAGERS
-

Client
 CANBERRA ISLAMIC CENTER INC.

Site
 BLOCK 4 SECTION 52 MONASH
 221 Clive Steele Avenue

Project
 STAGE 2 DEVELOPMENT
 OF CIC - ANIL COMPLEX

Drawing Title
 GROUND FLOOR PLAN

PROJECT NUMBER	Scale	1:100
CHECKED BY SH	Date	DEC. 2012
DRAWN BY JA	Rev	B
Drawing Number	North	
A10.02		

